



PROFESSIONAL CERTIFICATION  
I hereby certify the above documents were prepared or approved by me, and that I am a duly licensed professional engineer under the laws of the State of Maryland License No. SB854, Expiration Date: 12/31/24.


**CENTURY**  
**Site Plan Amendment F**  
**#82003007F**  
 Cloverleaf Center, Parcels Z & AA  
 Montgomery County, Maryland, Clarksburg Election District 2

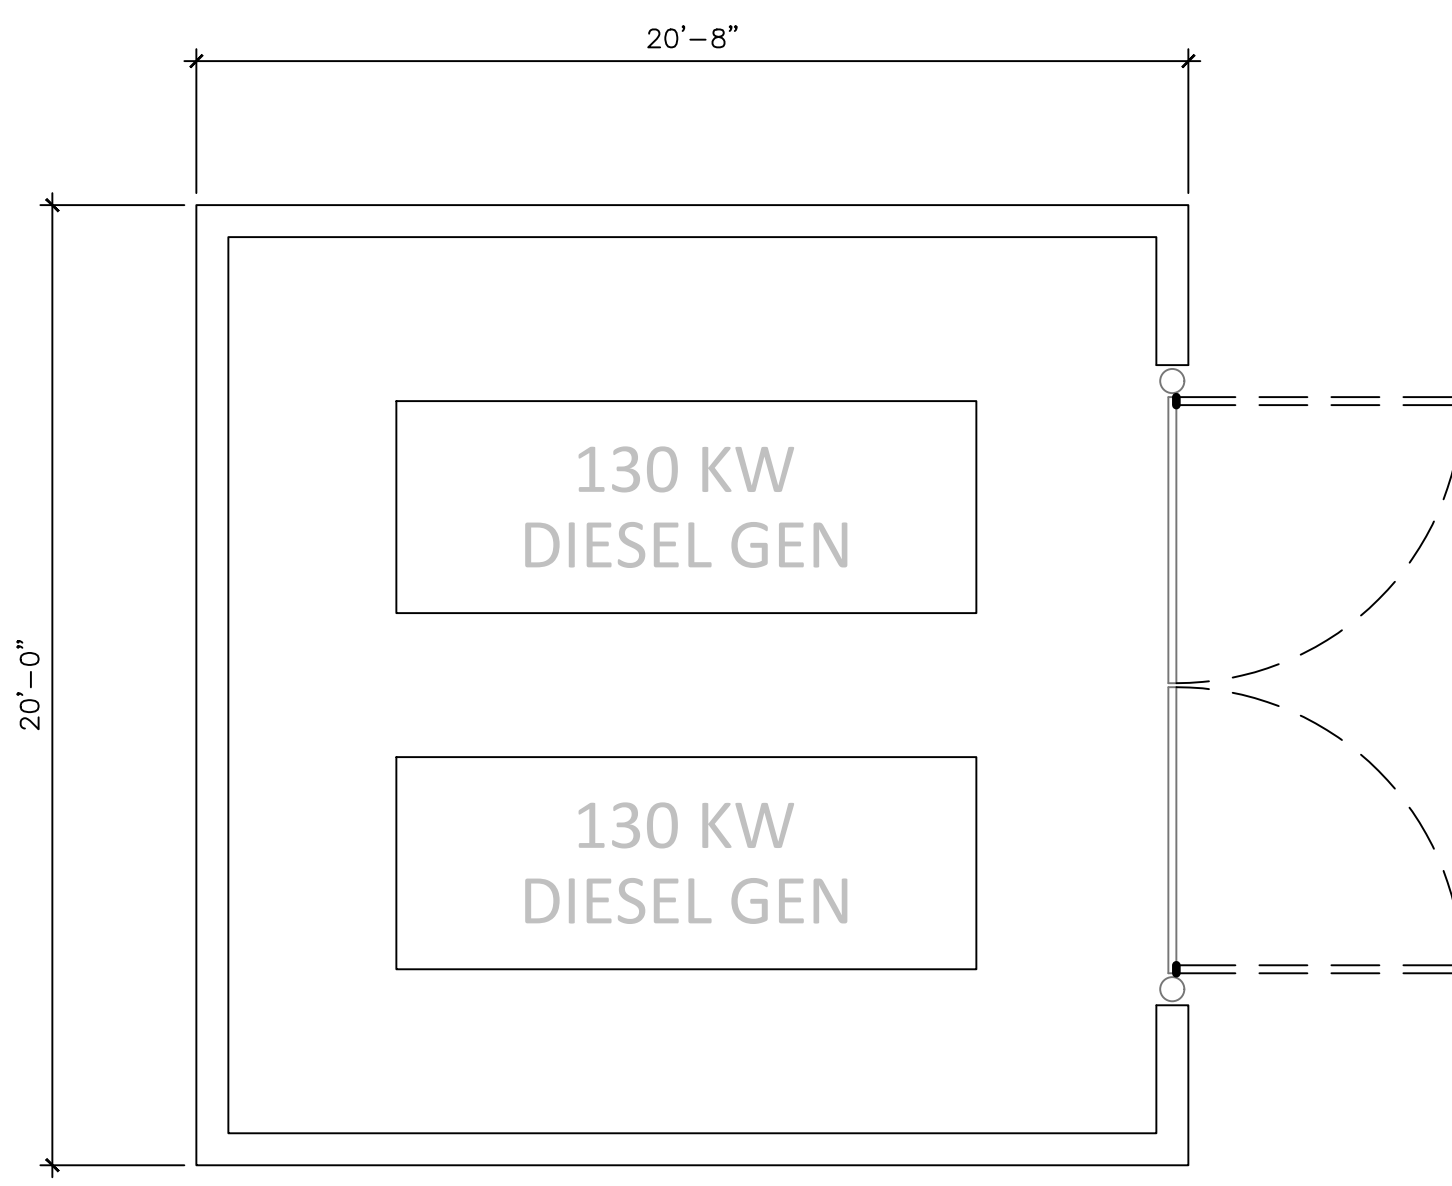


**1 - Generator Enclosure - Plan View (Typ.)**  
Scale: 1/4" = 1'-0"

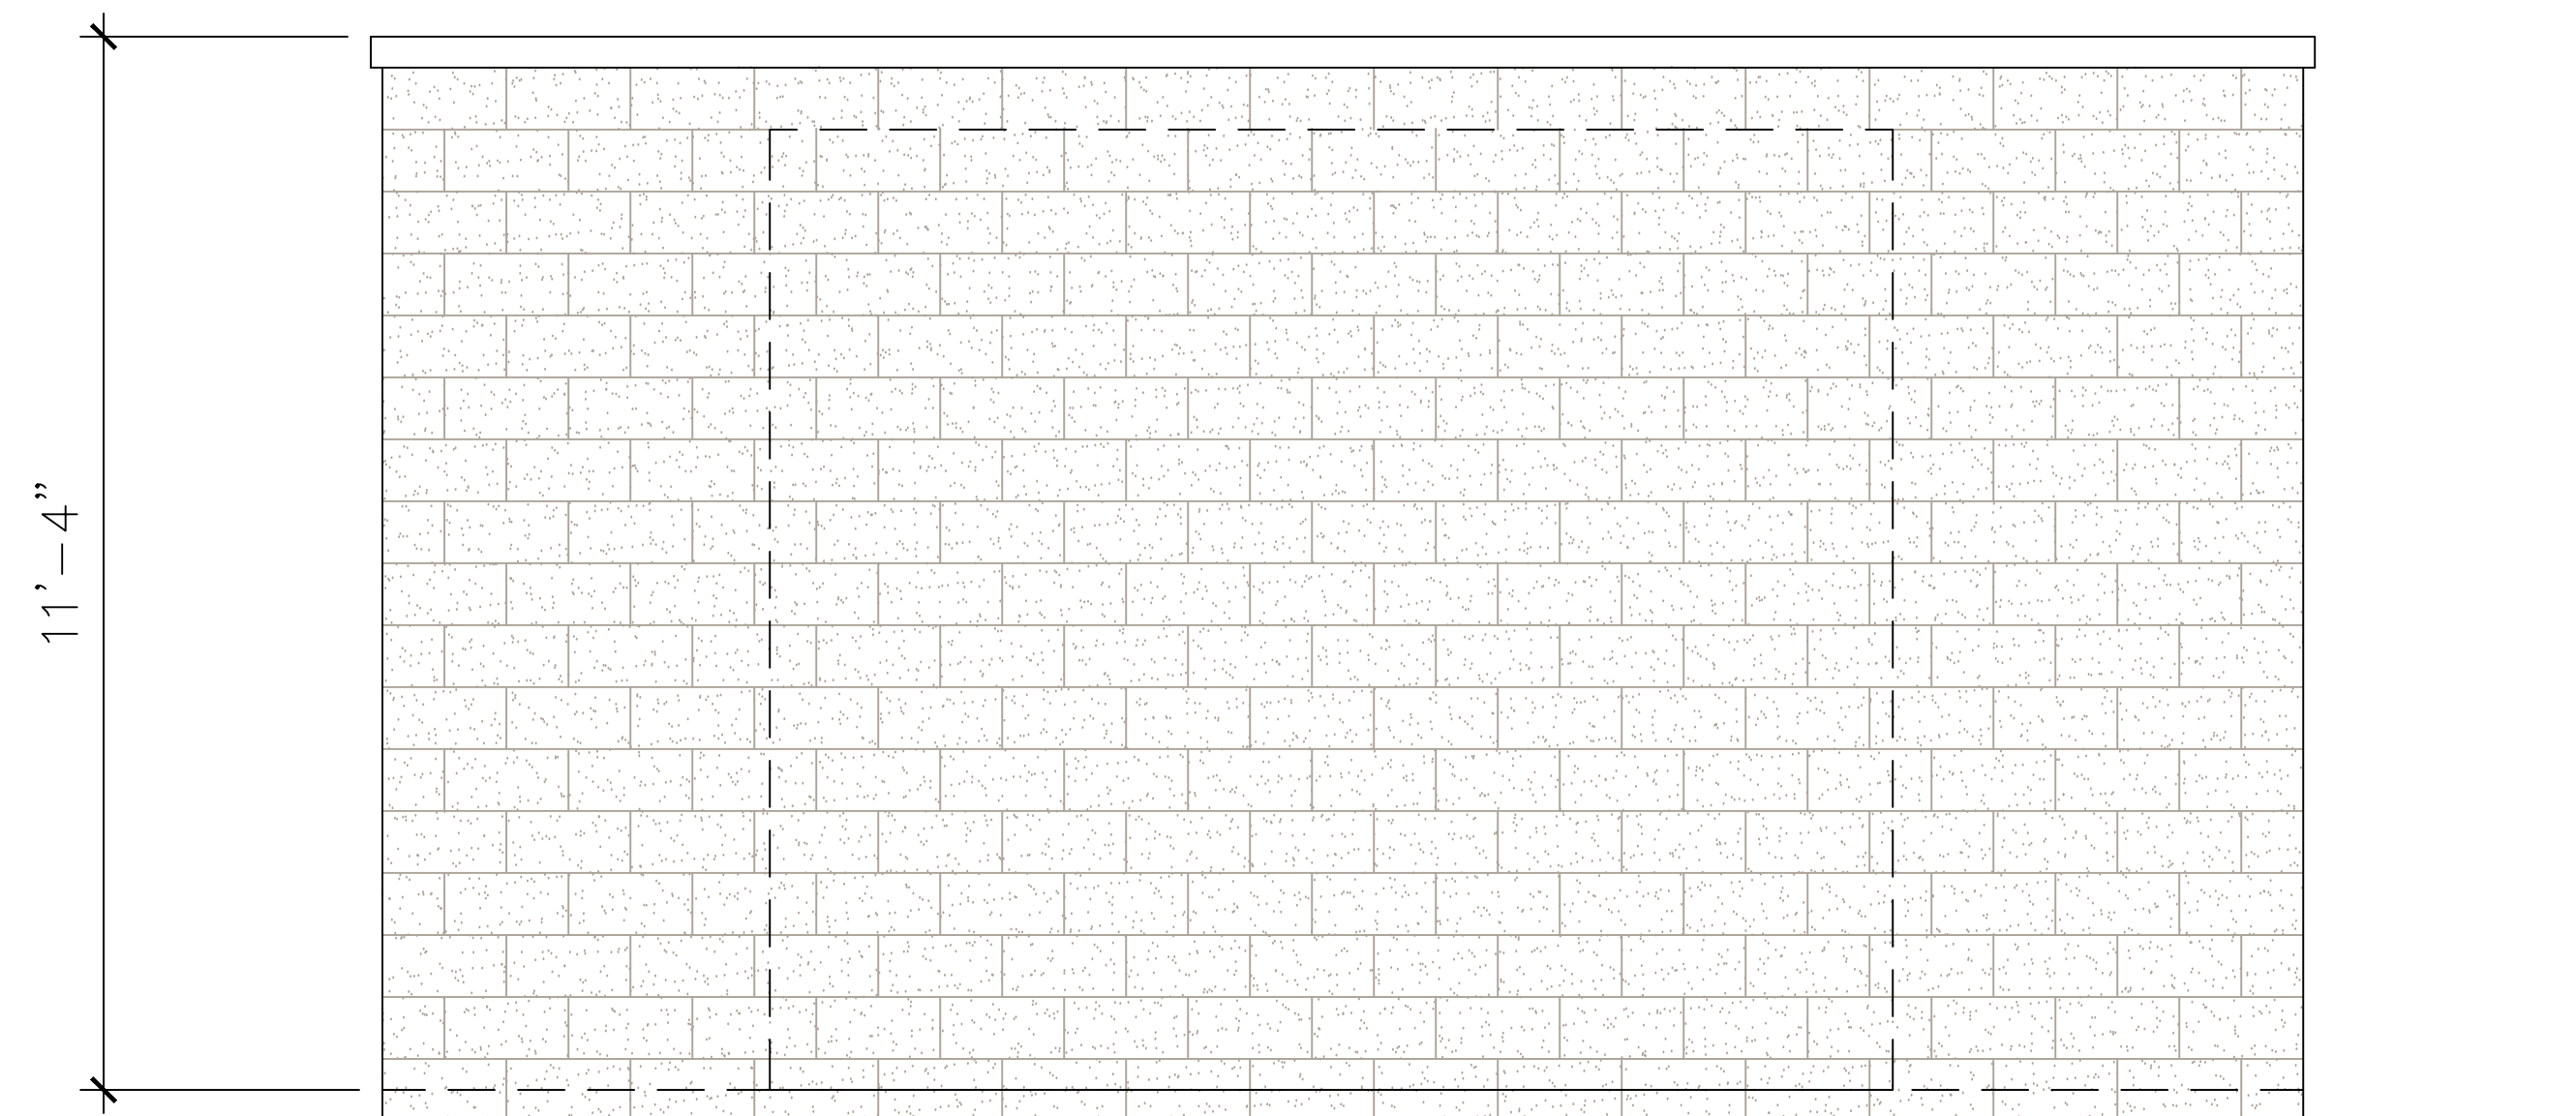

**3 - Generator Enclosure - Side Elevation (Typ.)**  
Scale: 1/2" = 1'-0"

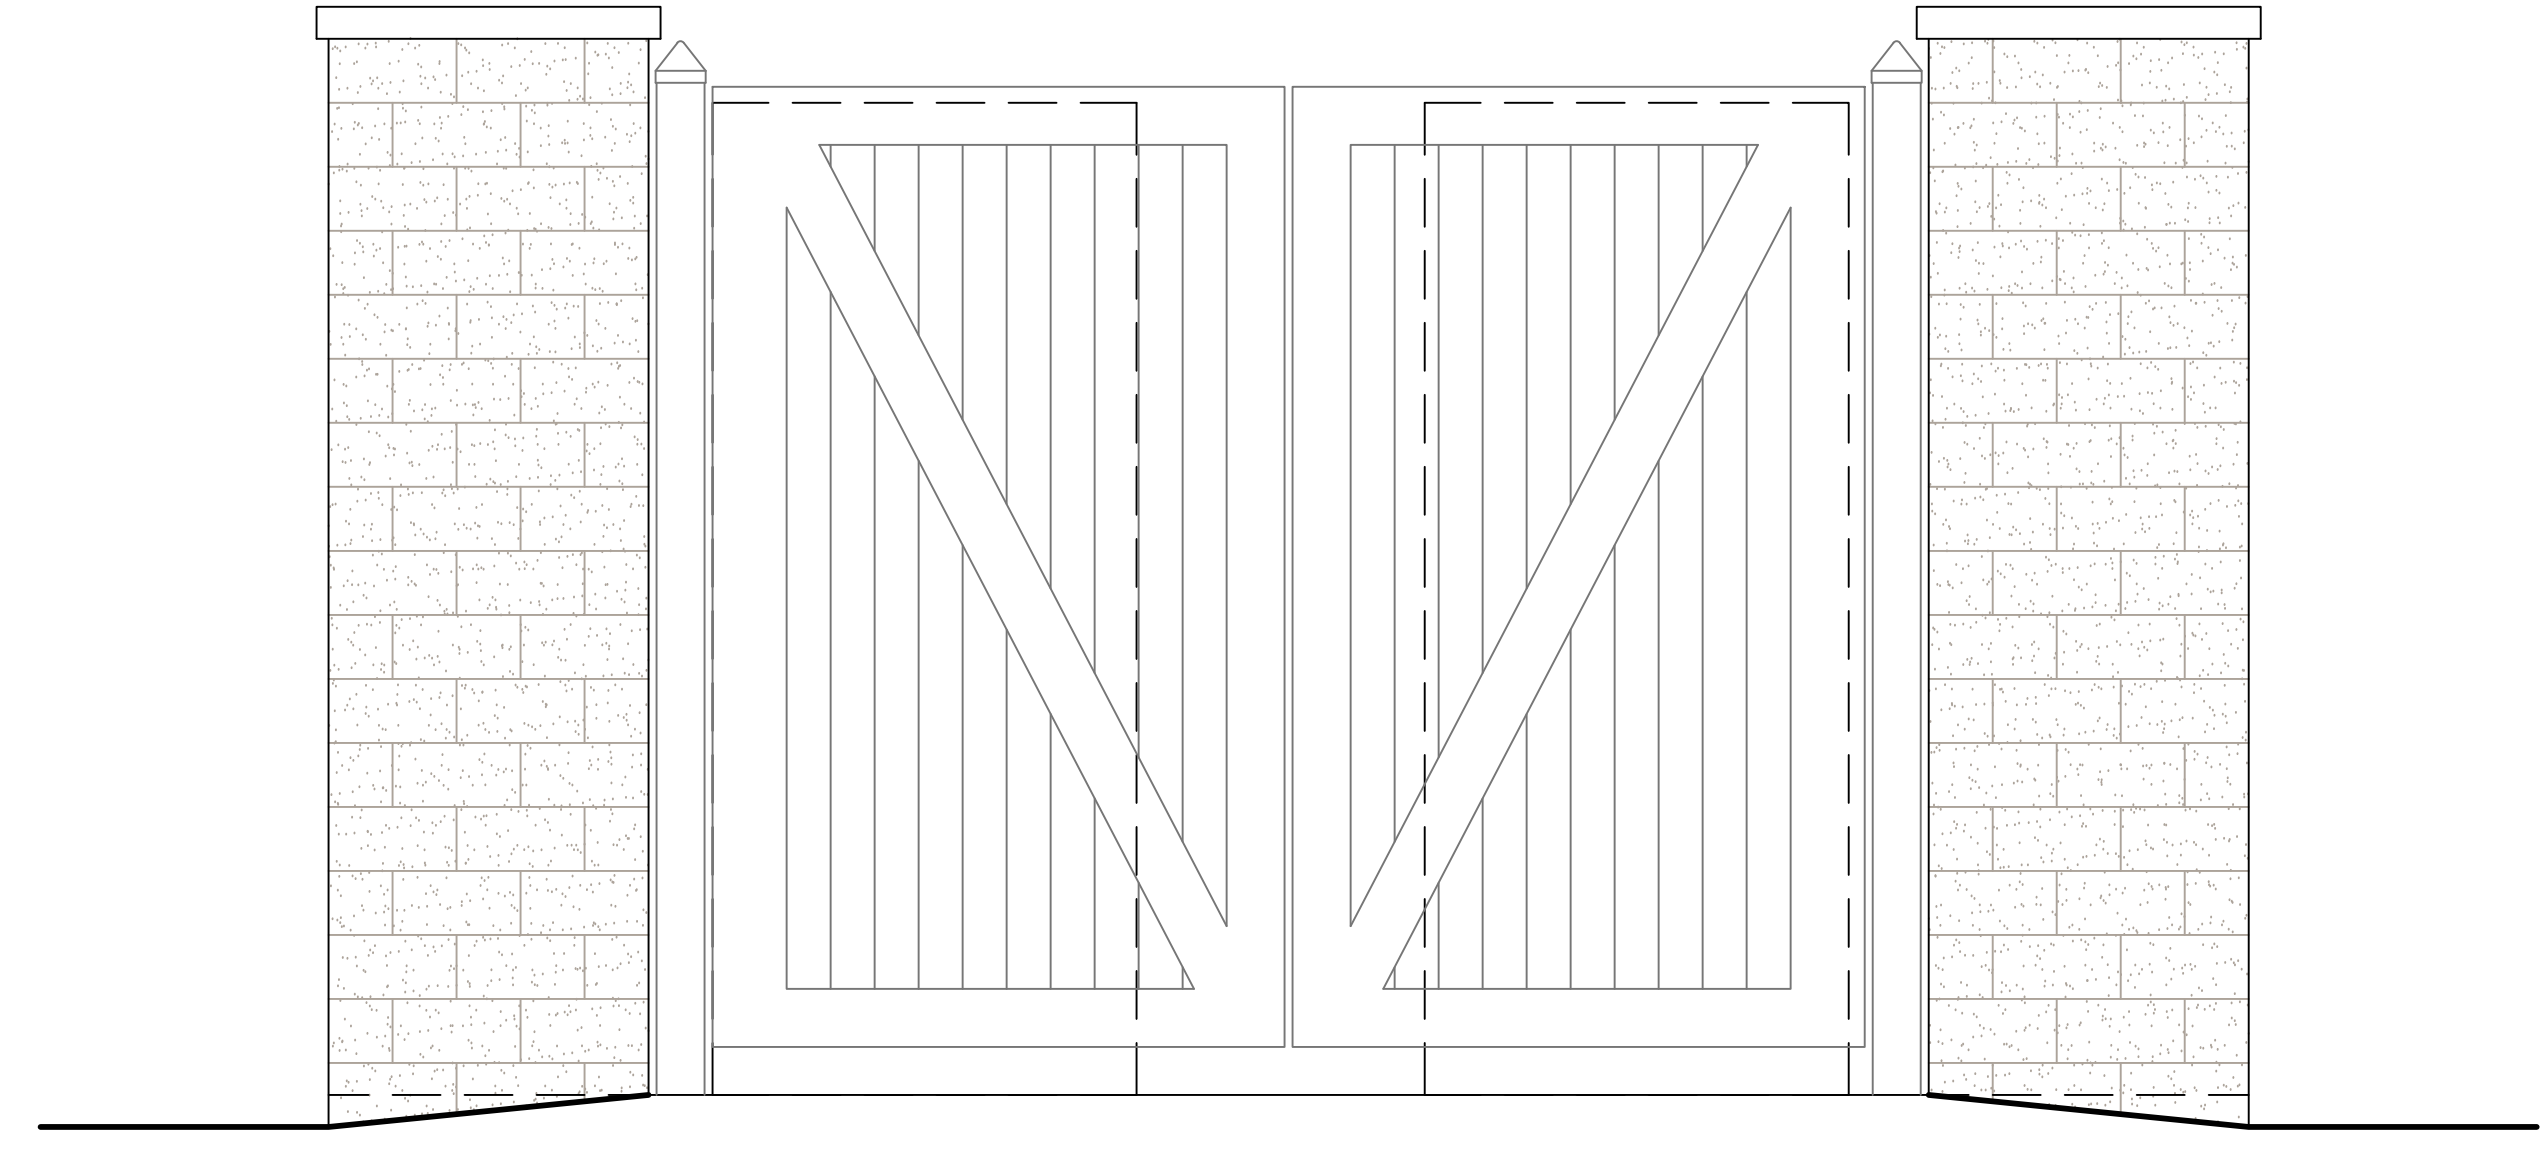

**2 - Generator Enclosure - Front Elevation (Typ.)**  
Scale: 1/2" = 1'-0"

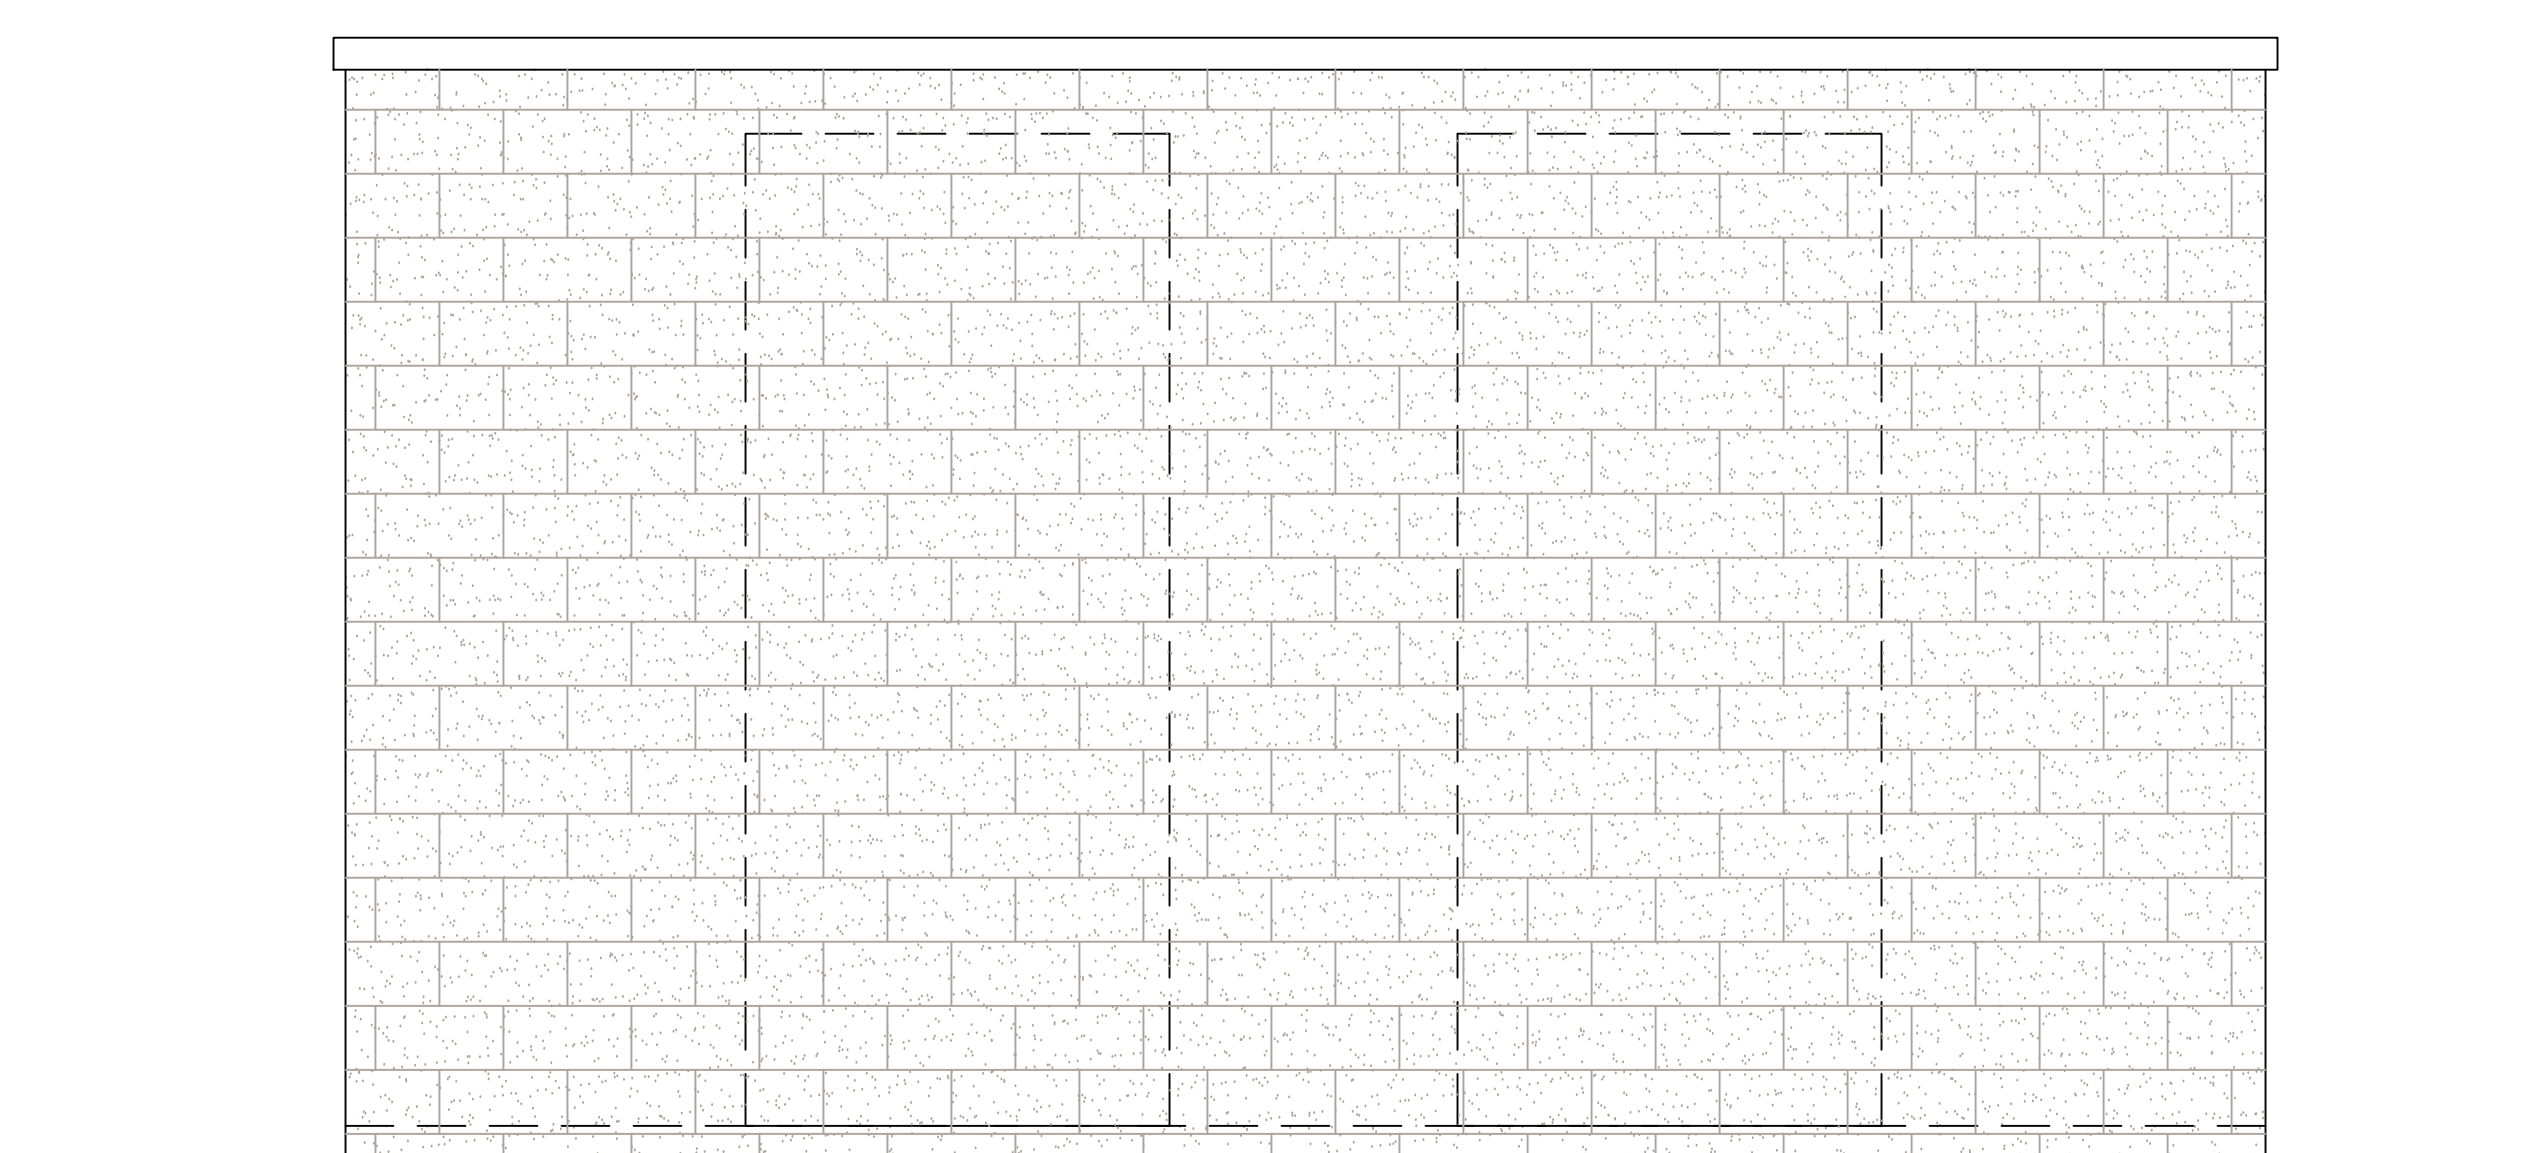

**4 - Generator Enclosure - Rear Elevation (Typ.)**  
Scale: 1/2" = 1'-0"

**LIST OF AMENDMENT ITEMS:**

1. RE-DESIGNED AREA I.C. LOCATED AT CLOVERLEAF CENTER SUBDIVISION LOTS 2,3, & 4, BLOCK A - FOR NEWLY PROPOSED BUILDINGS D, E, G, & H AND FUTURE C1/C2 PAD SITE.
2. NO SHEET CHANGE
3. REVISED DEVELOPMENT PROGRAM AND BUILDING USES.
4. REVISED DEVELOPMENT DATA TABLE AND /OR NOTES
5. RE-SUBDIVISION OF LOTS.
6. REVISED ARCHITECTURE.
7. REVISED LANDSCAPE/ LIGHTING LAYOUT AND ASSOCIATED PLANTING SCHEDULES.
8. REVISED UTILITY / WATER & SEWER LAYOUT CONNECTION FOR EACH PROPOSED BUILDING.
9. REVISED SITE PLAN SHEET NUMBERS TO ACCOUNT FOR NEW SHEETS ADDED PER AMENDMENT.
10. REVISED SHEET MATCH LINES PER REVISED LAYOUT.
11. REVISED AMENITY AND PROGRAMMED SPACES AROUND NEW PROPOSED BUILDINGS.
12. REVISED DEVELOPMENT PHASING.
13. ADD / REMOVED DETAILS PER PROPOSED AMENDMENT.
- 14.

- NOTE:**
1. DRAWINGS FOR ILLUSTRATIVE PURPOSES ONLY.
  2. GENERATOR ENCLOSURE STONE TO MATCH ARCHITECTURE .

**Developer's Certificate**  
The Undersigned agrees to execute all the features of the Site Plan Approval No. 82003007F including Approval Conditions, Development Program, and Certified Site Plan.

Developer: Shamit Development Company Pradip Ghosh  
Company Contact Person

Address: 4495 Montgomery Road, Ellicott City, MD 21043

Phone: (443) 802-9077

Signature: Pradip Ghosh

KEY PLAN

ISSUE DATE	DESCRIPTION
2021.10.29	M-NCPPC - Initial Submission
2021.11.30	M-NCPPC - In-Take Submission
2022.04.14	M-NCPPC - Post DRC Submission
2023.05.31	M-NCPPC - 2nd Post DRC Submission

REVISIONS NO.	DATE	DESCRIPTION
2		

PROJECT NUMBER: 1252A1  
DATE: 2022.04.14  
SCALE: AS SHOWN  
DRAWING TITLE: Architectural Plan